


NOTES:  
 1. REFER TO W3-6001 FOR DRAWING INDEX, SETOUT DETAILS, GENERAL NOTES AND LEGEND.  
 2. REFER TO W3-6002 FOR SET OUT TABLES.



File: P:\65365102\3 PROJECT INPUTS\3.1 LADD\DOWNER\31668 FROM SHONTE\TONKIN\2018\31668\PROJECT\W3\6002\DRW\WD-6205-AB.DWG  
 Plot Date: 24/06/2018 9:58:21 AM  
 Office:

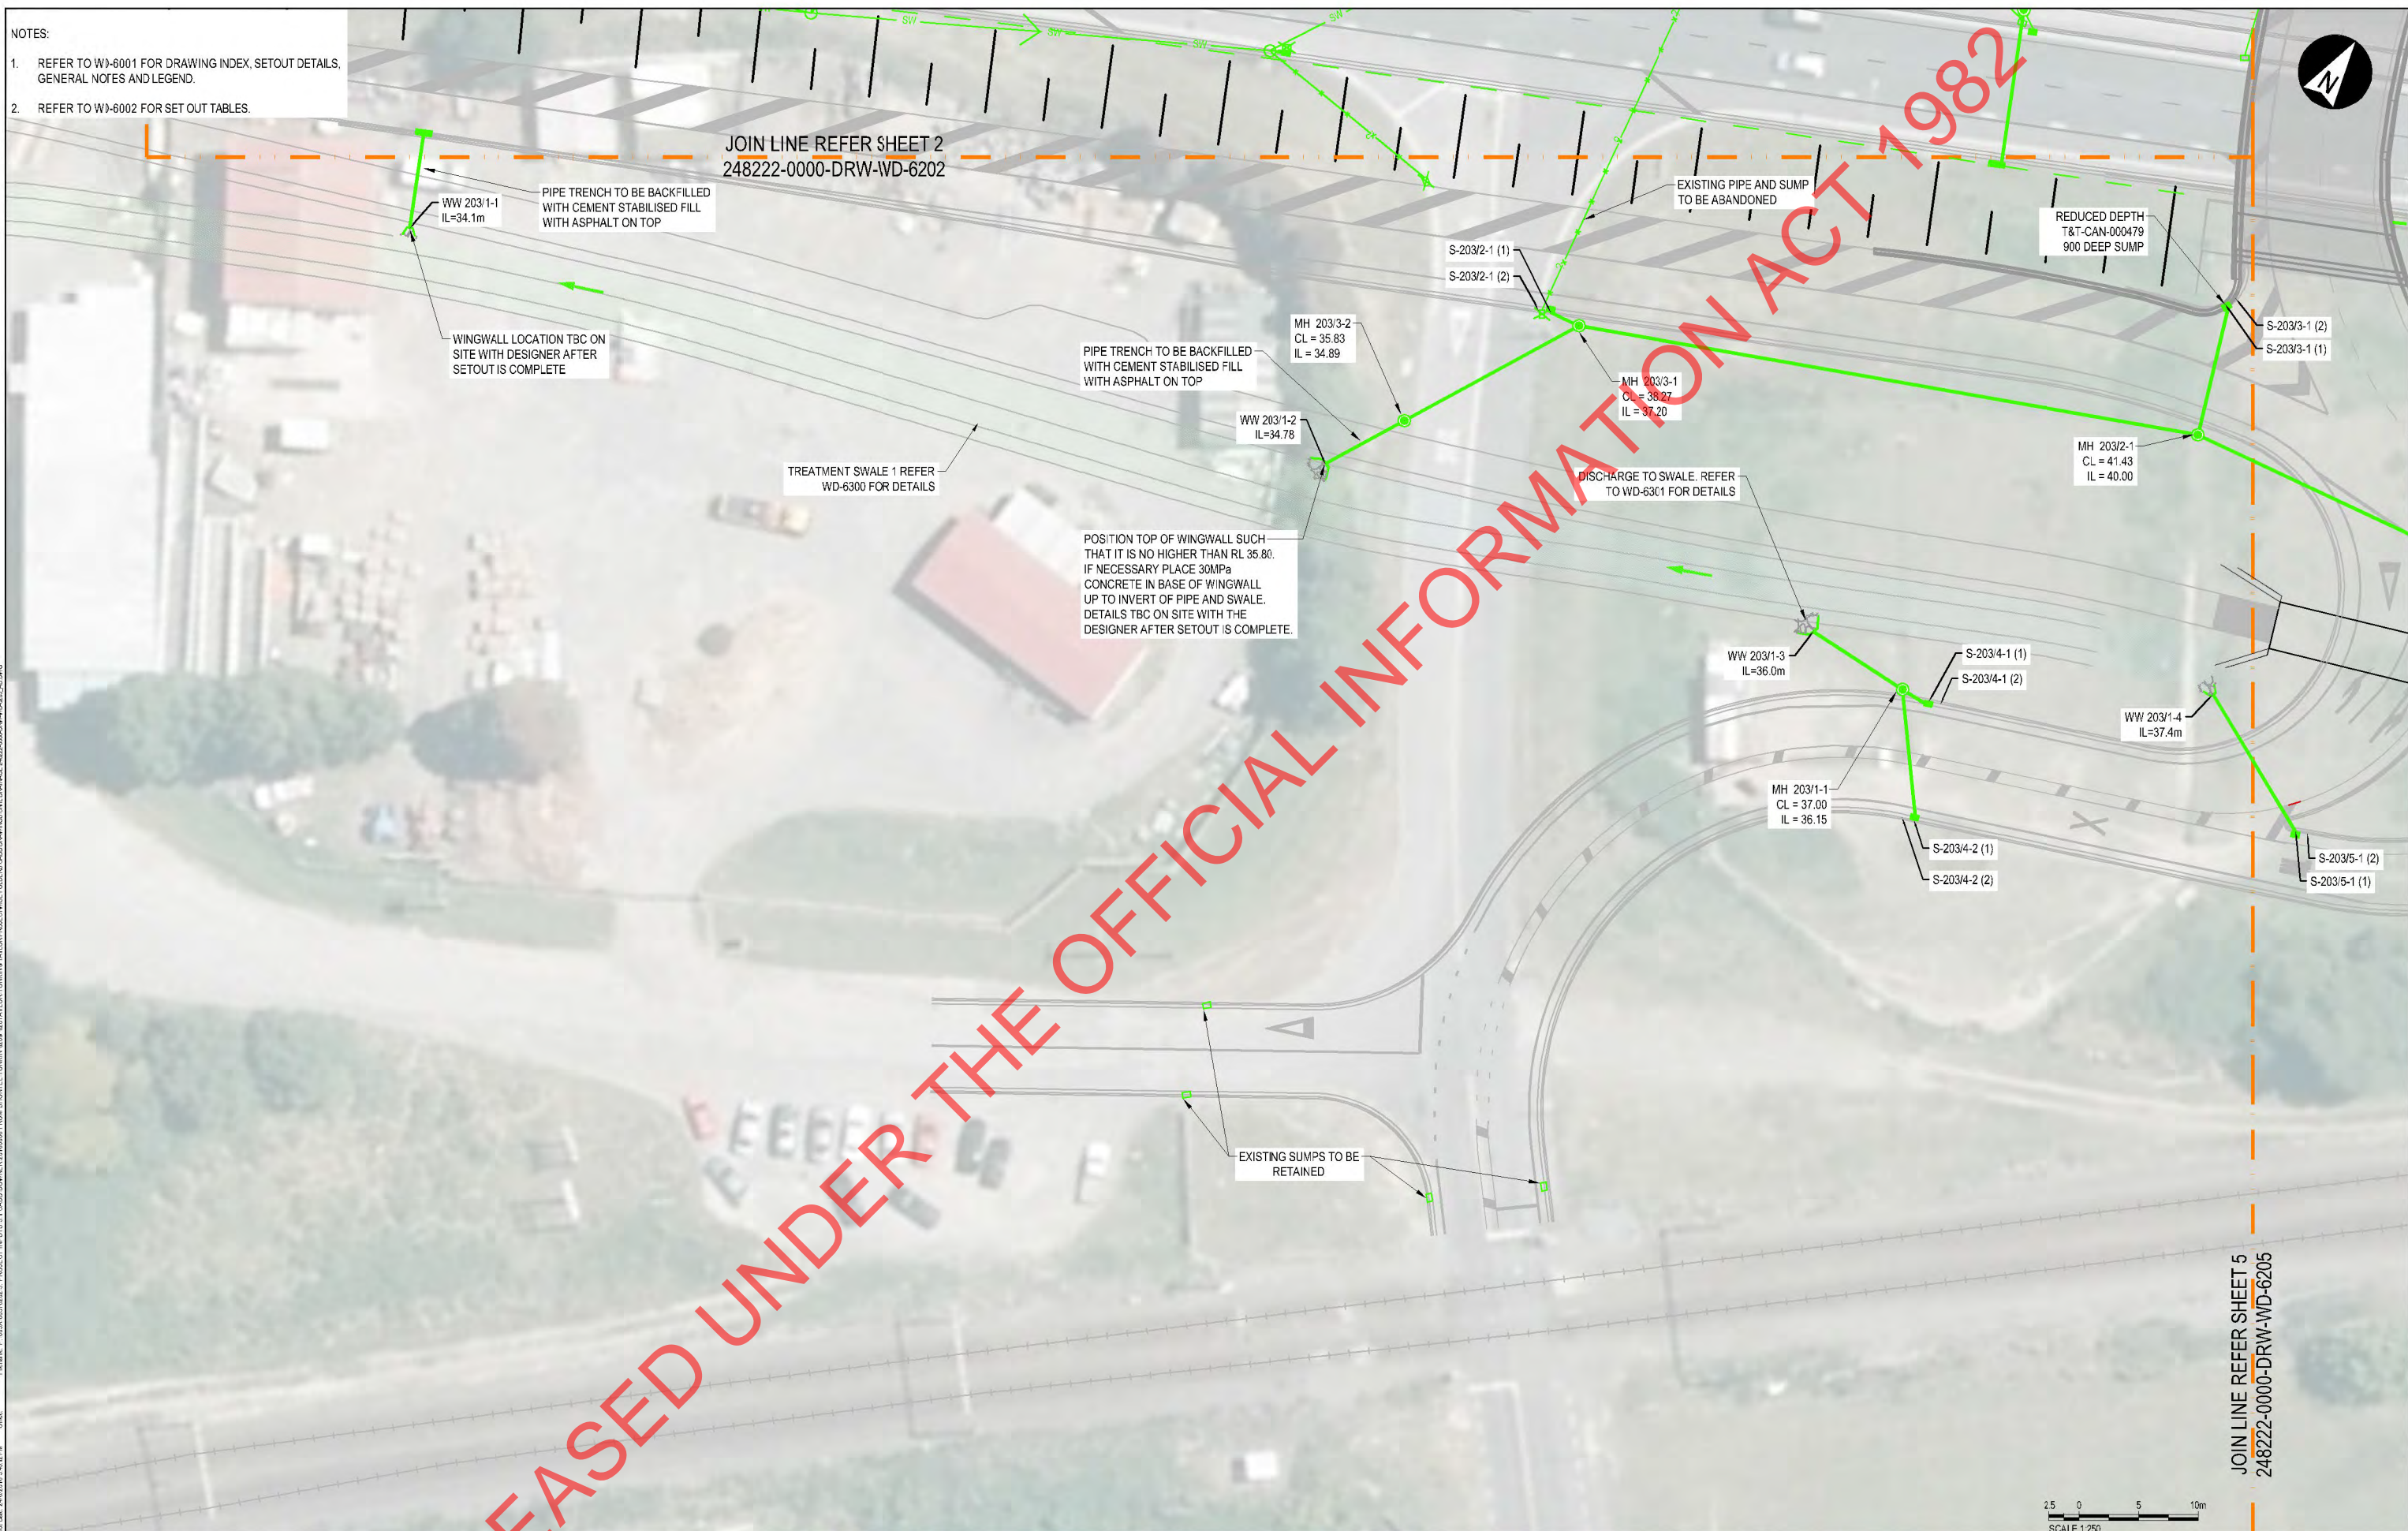

REV	DATE	REVISION DETAILS	APPROVED
AB	29.06.18	AS BUILT	

SCALE	SIZE
1:250	A1
DRAWN	
s9(2)(a)	
DESIGNED	
s9(2)(a)	
CHECKED	
s9(2)(a)	

AS BUILT	APPROVED	DATE

CLIENT	PROJECT
SH2 - SH58 HAYWARDS INTERCHANGE	SH2 - SH58 HAYWARDS INTERCHANGE
TITLE	STORMWATER DRAINAGE LAYOUT PLAN SHEET 3 OF 8
DRAWING No.	248222
PROJECT No.	0000
WBS	DRW
TYPE	WD
DISC	
NUMBER	6203
REV	AB