


- NOTES:
- REFER TO W3-6001 FOR DRAWING INDEX, SETOUT DETAILS, GENERAL NOTES AND LEGEND.
 - REFER TO W3-6002 FOR SET OUT TABLES.

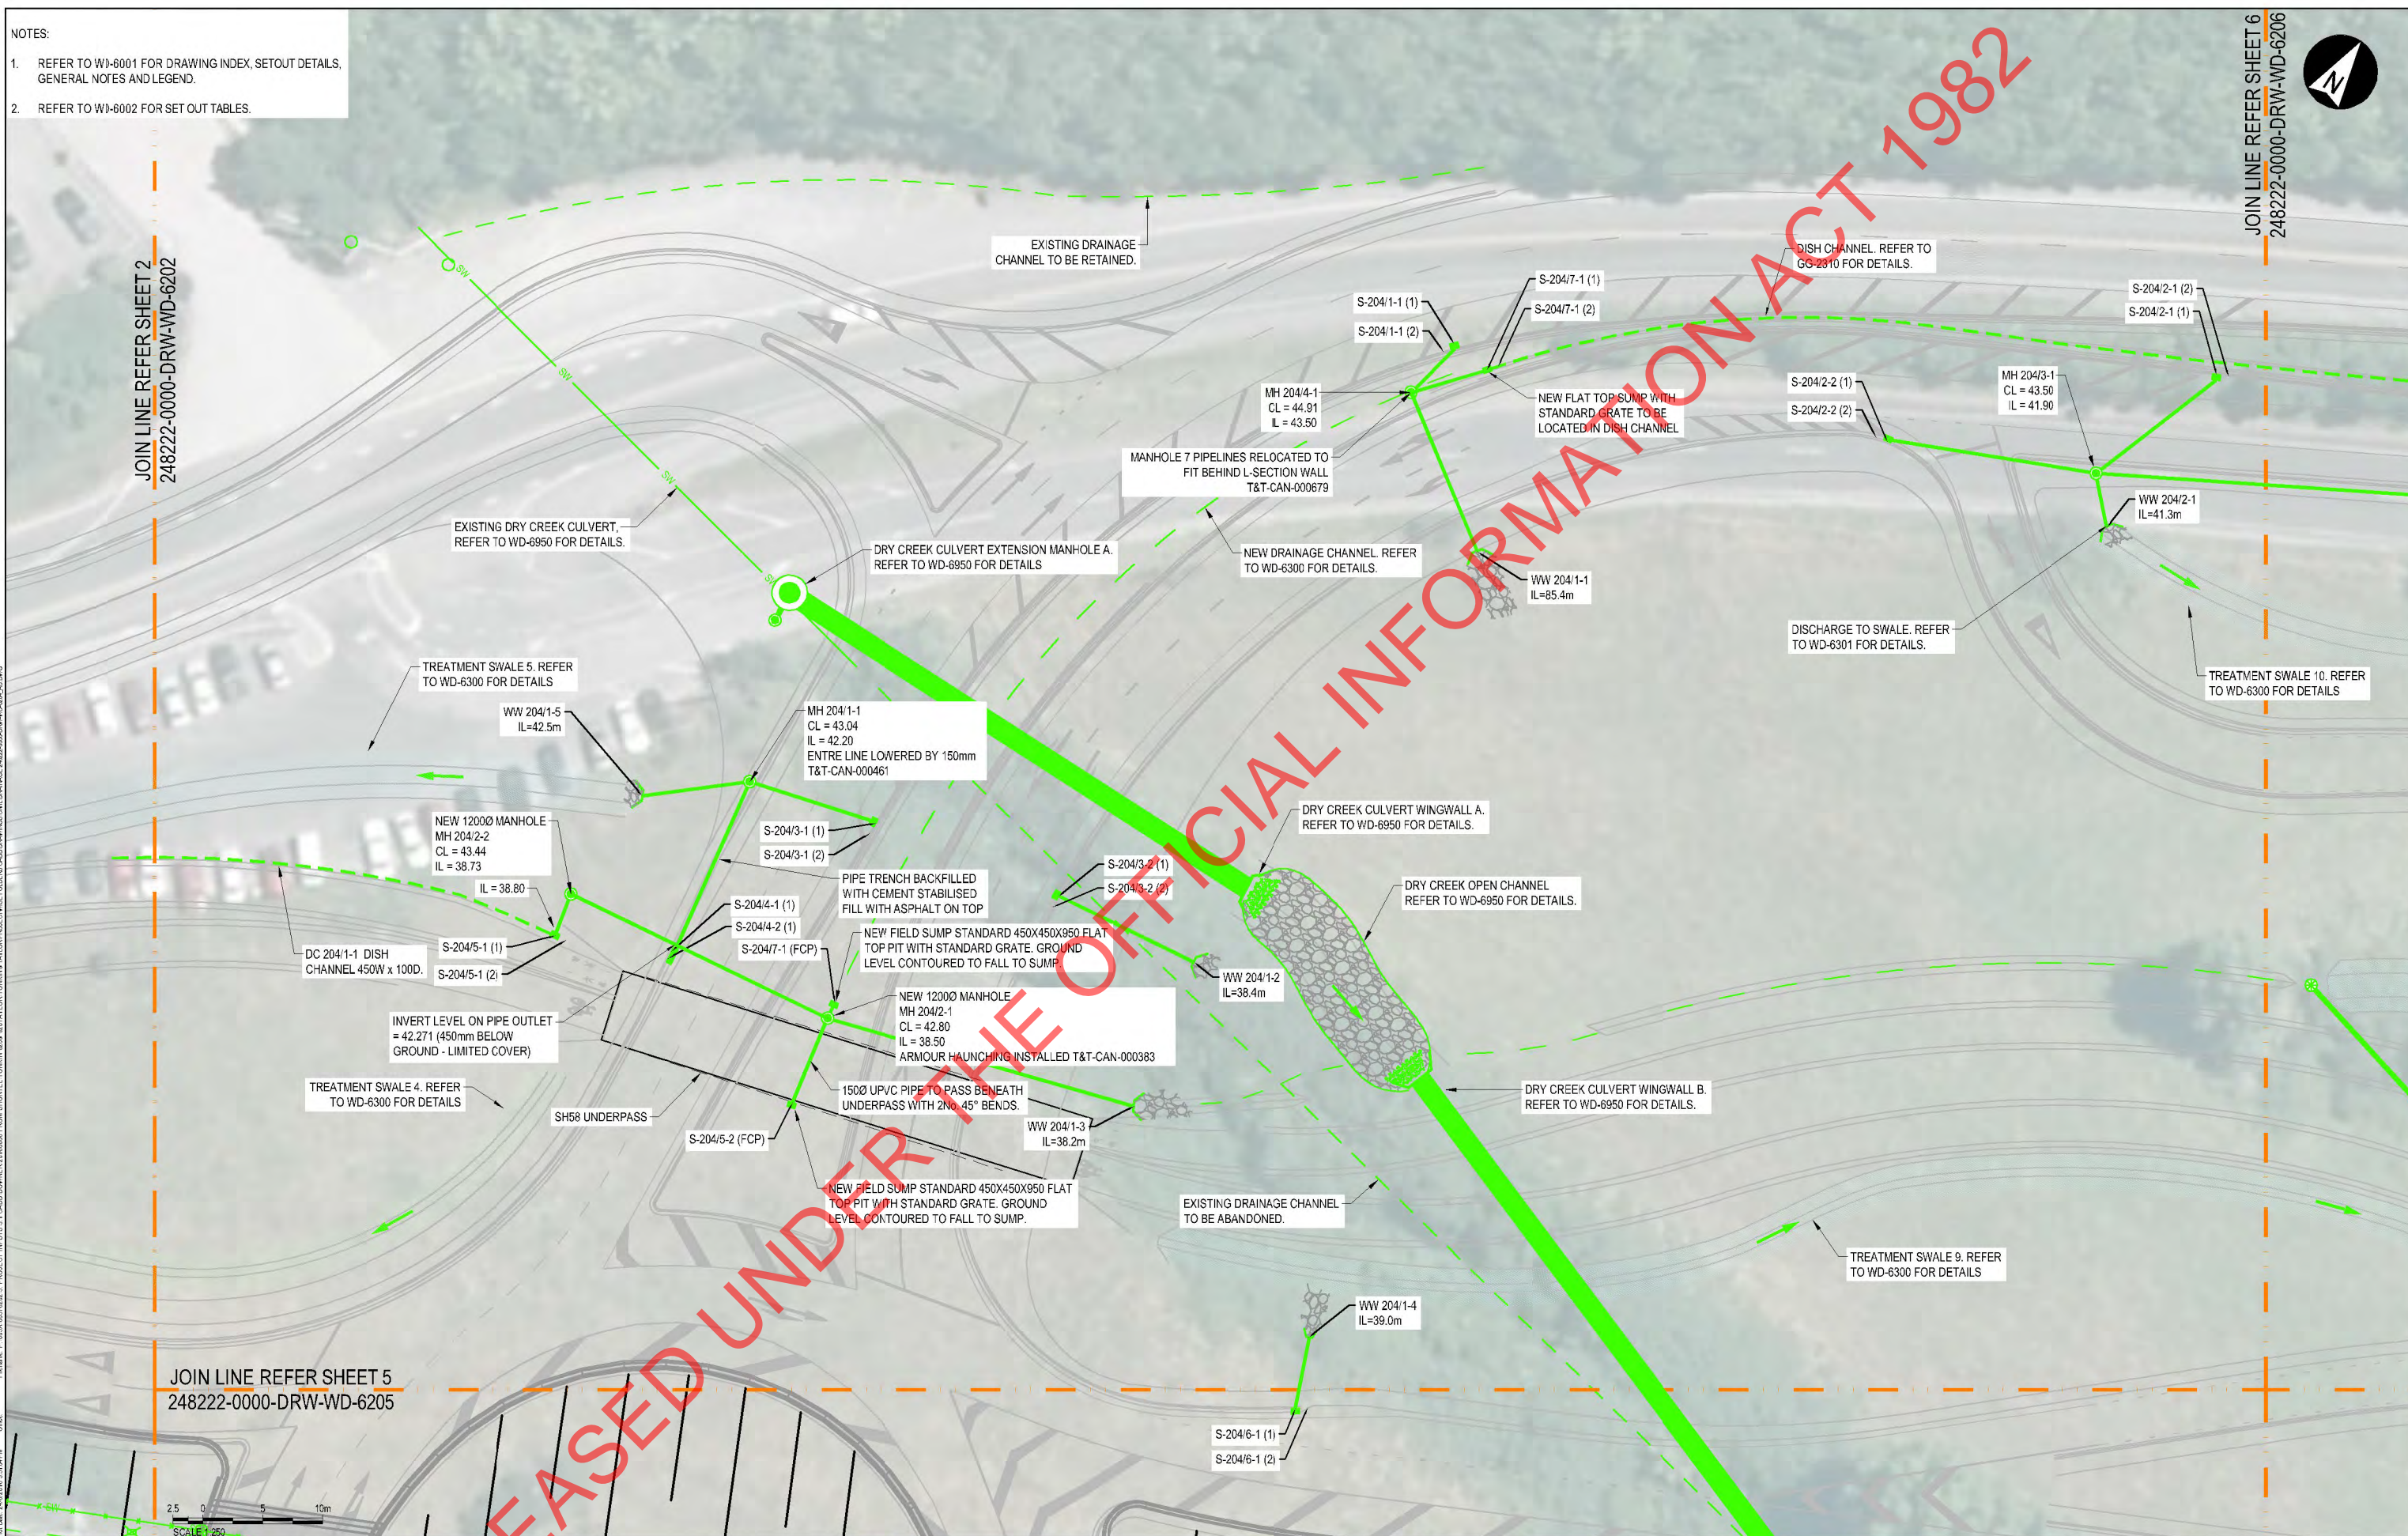

JOIN LINE REFER SHEET 2
248222-0000-DRW-WD-6202

JOIN LINE REFER SHEET 6
248222-0000-DRW-WD-6206

JOIN LINE REFER SHEET 5
248222-0000-DRW-WD-6205

SCALE 1:250



REV	DATE	REVISION DETAILS	APPROVED
AB	23.03.16	AS BUILT	

SCALE	SIZE
1:250	A1
DRAWN	
s9(2)(a)	
DESIGNED	
s9(2)(a)	
CHECKED	
s9(2)(a)	

AS BUILT

APPROVED

CLIENT	PROJECT
SH2 - SH58 HAYWARDS INTERCHANGE	SH2 - SH58 HAYWARDS INTERCHANGE
TITLE	STORMWATER DRAINAGE LAYOUT PLAN SHEET 4 OF 8
DRAWING No.	248222
PROJECT No.	248222
WBS	0000
TYPE	DRW
DISC	WD
NUMBER	6204
REV	AB