


NOTES:
 1. REFER TO W3-6001 FOR DRAWING INDEX, SETOUT DETAILS, GENERAL NOTES AND LEGEND.
 2. REFER TO W3-6002 FOR SET OUT TABLES.

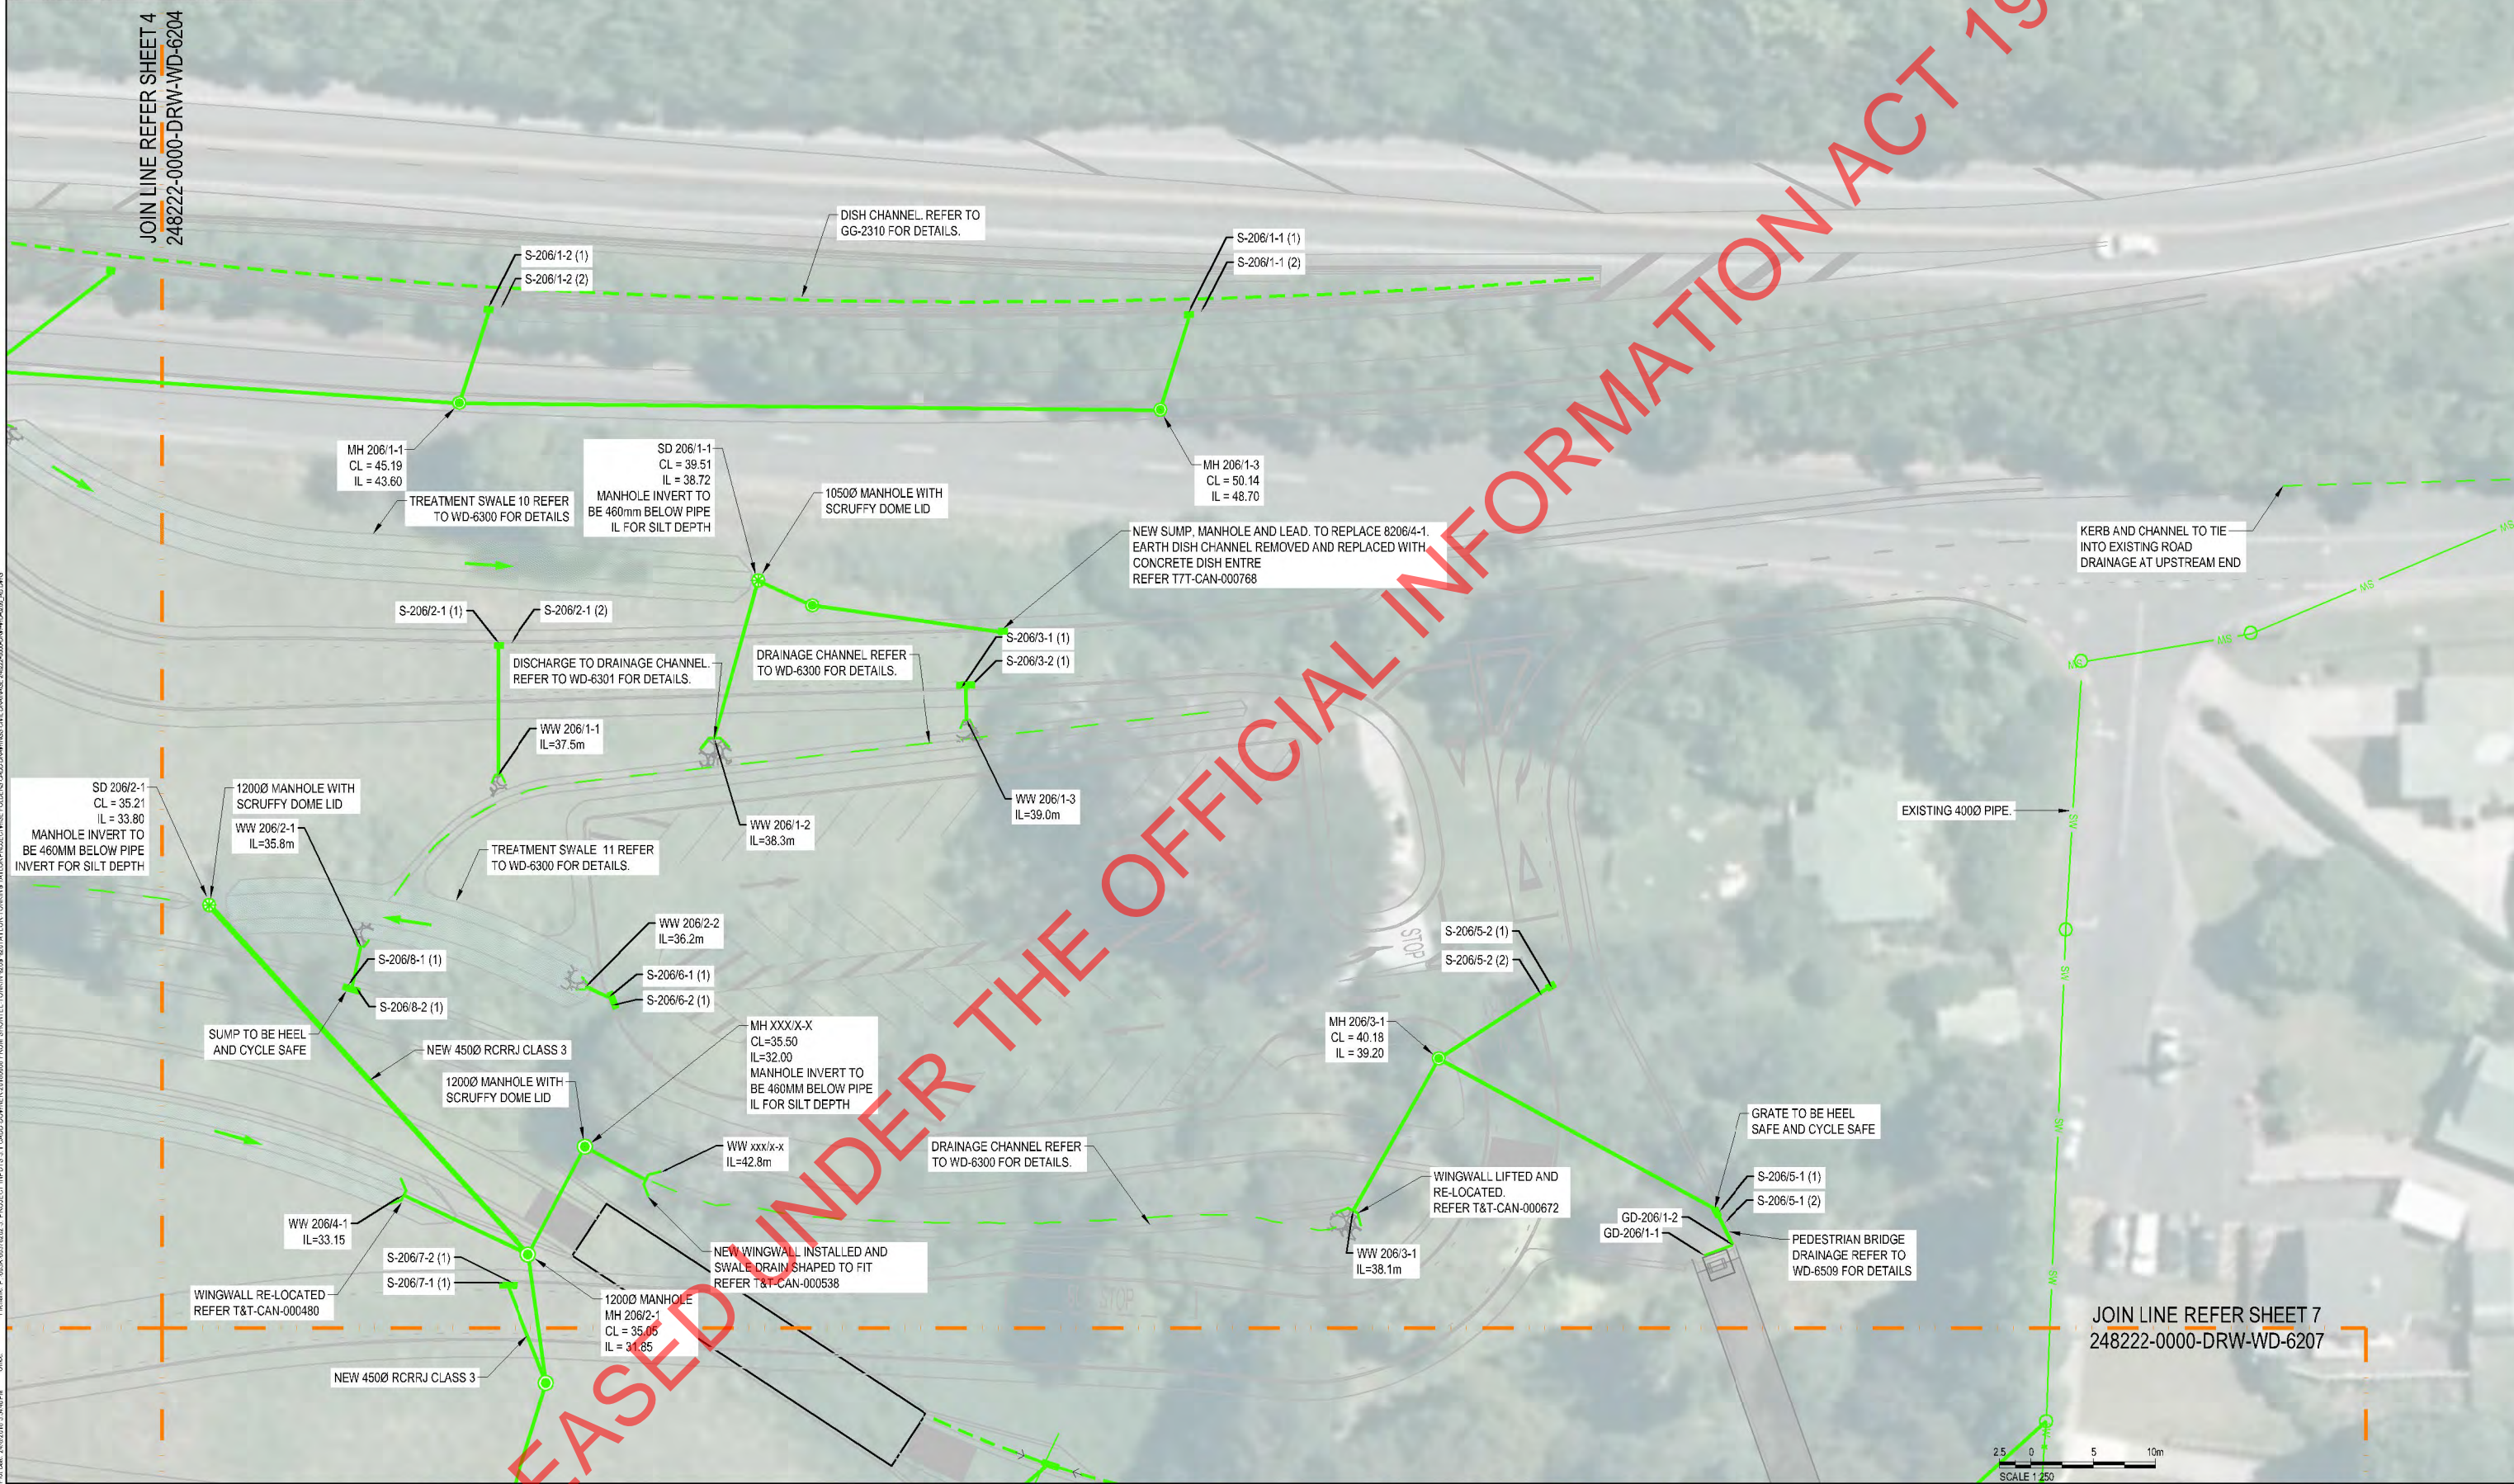

REV	DATE	REVISION DETAILS	APPROVED
AB	29.06.18	AS BUILT	

SCALE	1:250
SIZE	A1
DRAWN	s9(2)(a)
DESIGNED	s9(2)(a)
CHECKED	s9(2)(a)

AS BUILT	APPROVED	DATE
----------	----------	------

CLIENT	SH2 - SH58 HAYWARDS INTERCHANGE										
PROJECT	STORMWATER DRAINAGE LAYOUT PLAN SHEET 6 OF 8										
DRAWING No.	248222	WBS	0000	TYPE	DRW	DISC	WD	NUMBER	6206	REV	AB

RELEASED UNDER THE OFFICIAL INFORMATION ACT 1982

File: P:\65461610\2013 PROJECT INPUTS\11 LOADS\DOWNER\248222\0000\DRAWINGS\CAN\DRAINAGE\248222-0000-DRW-WD-6206.dwg
 Plot Date: 15/06/2018 9:54:08 AM
 Plotter: P:\65461610\2013 PROJECT INPUTS\11 LOADS\DOWNER\248222\0000\DRAWINGS\CAN\DRAINAGE\248222-0000-DRW-WD-6206.dwg