


- NOTES:
- REFER TO WD-6001 FOR DRAWING INDEX, SETOUT DETAILS, GENERAL NOTES AND LEGEND.
  - REFER TO WD-6002 FOR SET OUT TABLES.

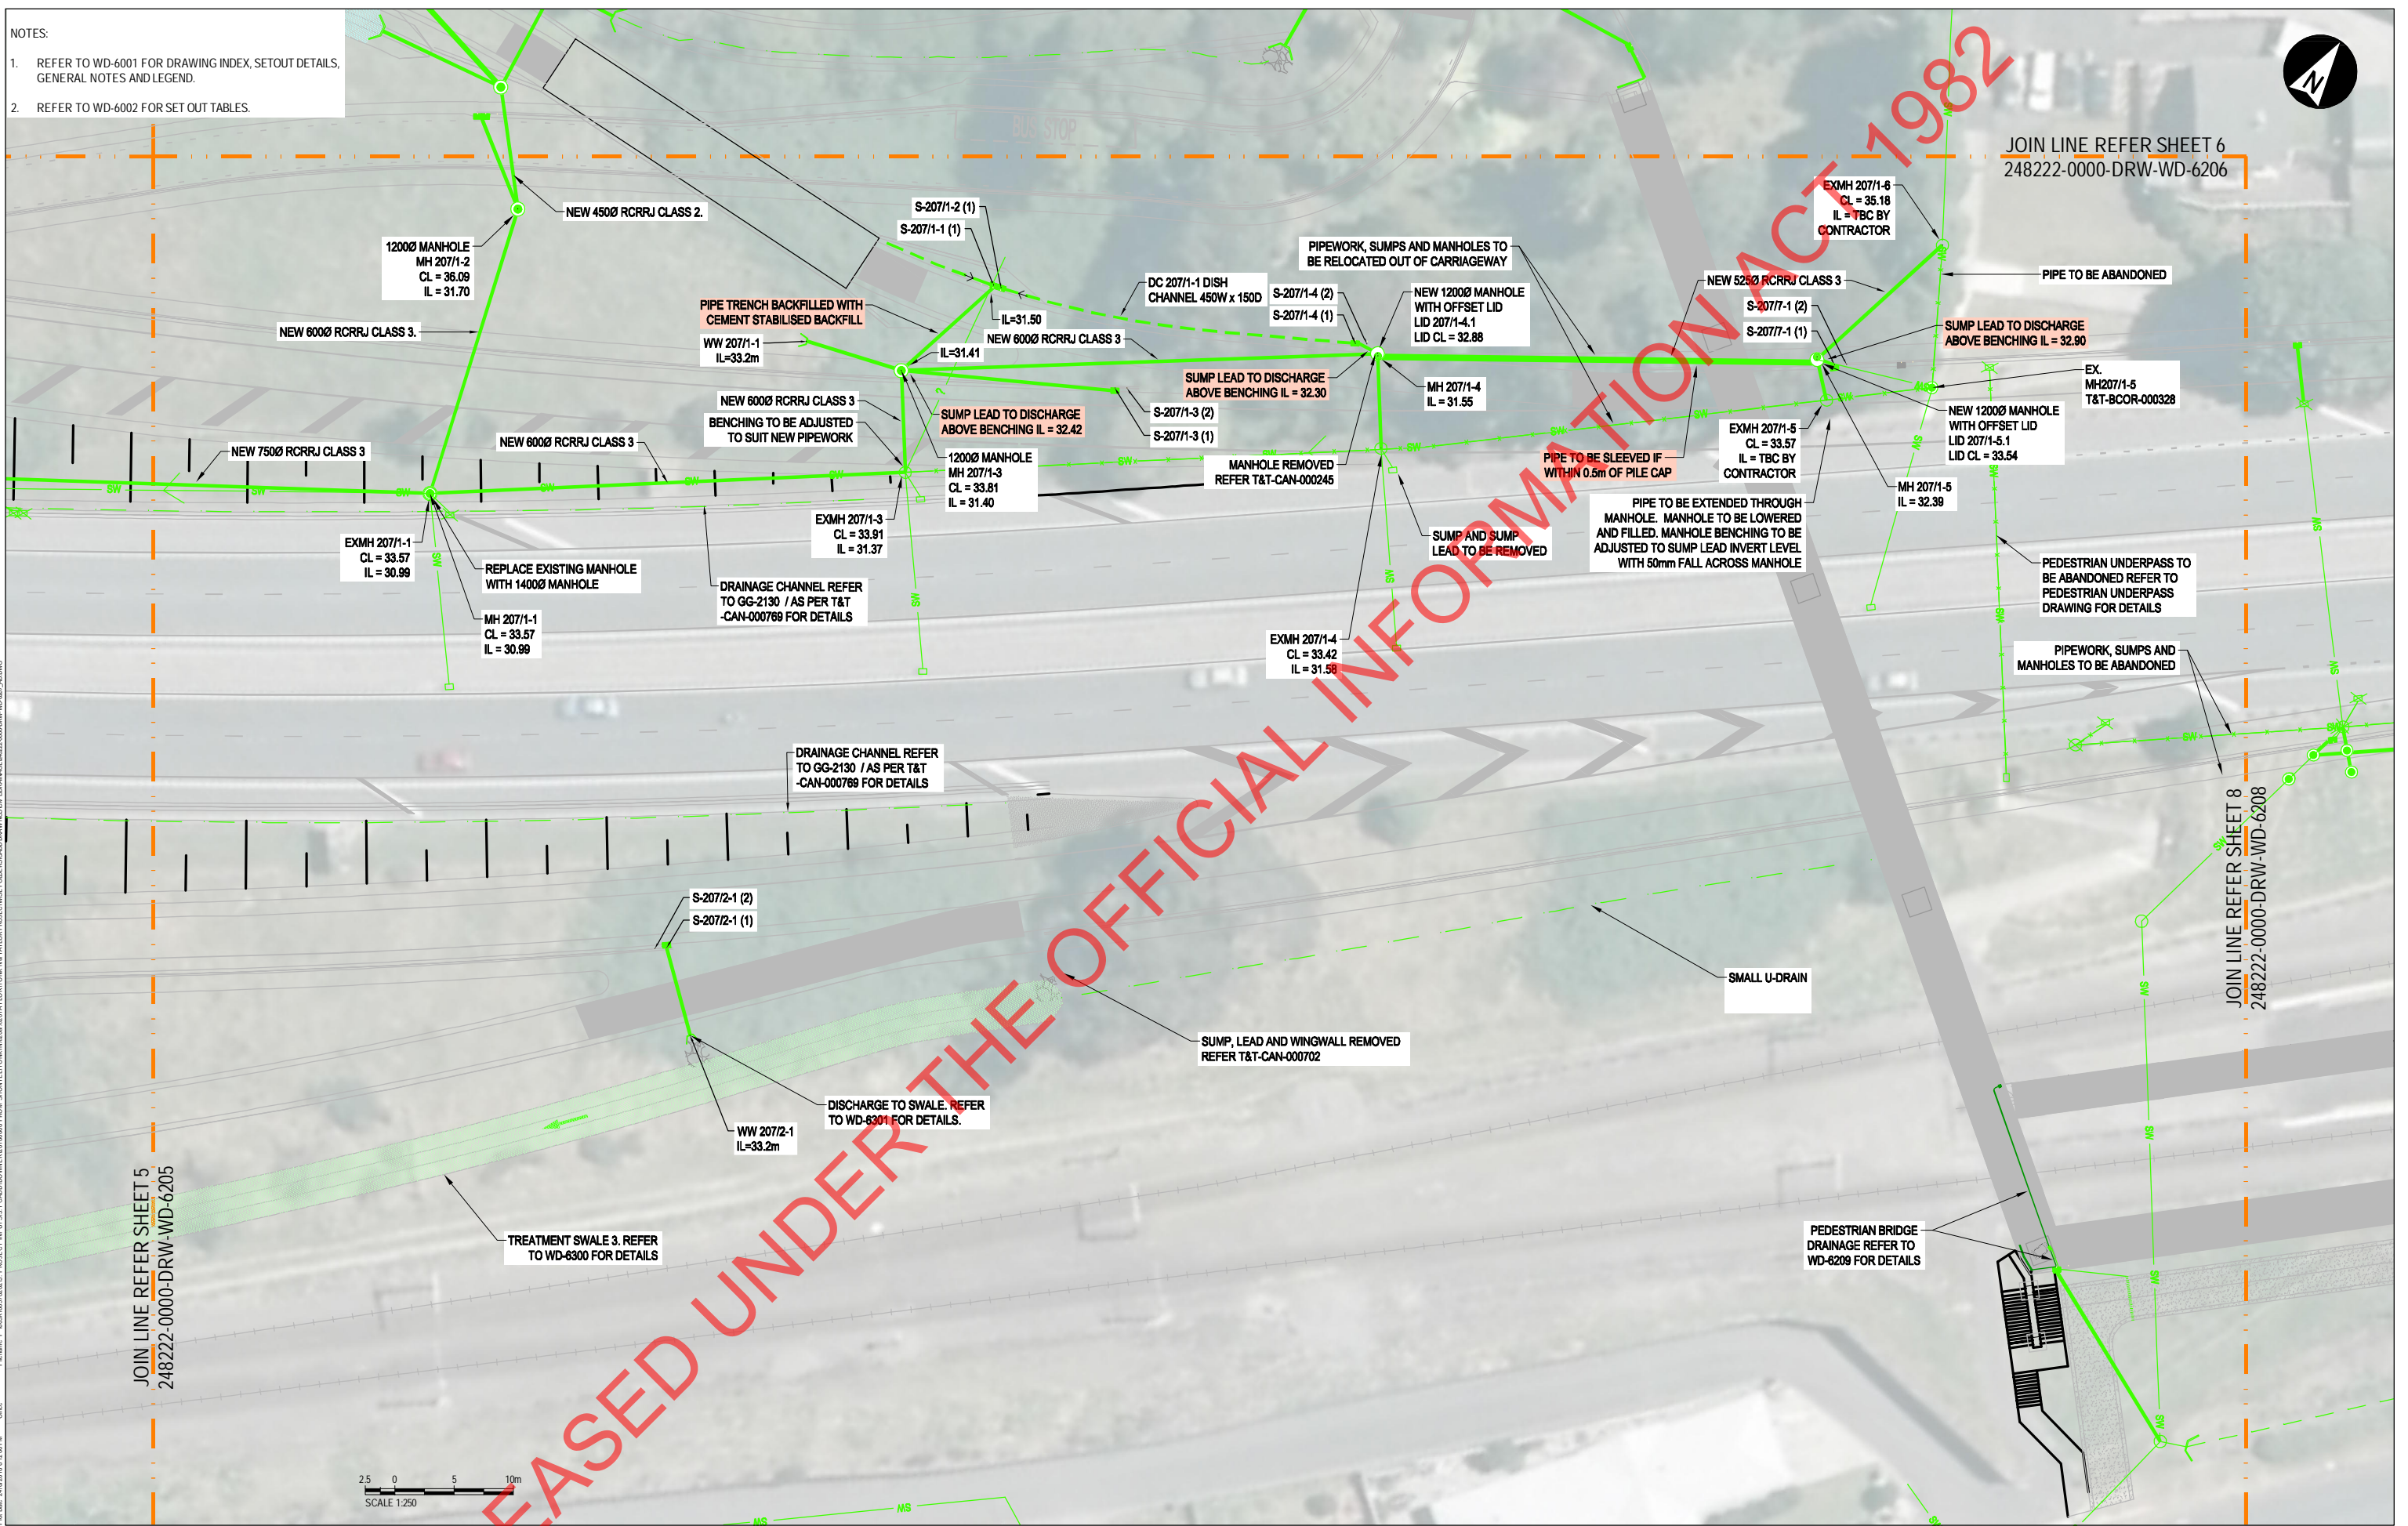

REV	DATE	REVISION DETAILS	APPROVED
AB	29.06.18	AS BUILT	

SCALE	SIZE
1:250	A1

AS BUILT	APPROVED	DATE

PROJECT	SH2 - SH58 HAYWARDS INTERCHANGE
TITLE	STORMWATER DRAINAGE LAYOUT PLAN SHEET 7 OF 8
DRAWING No.	248222 - 0000 - DRW - WD - 6207
PROJECT No.	248222
WBS	0000
TYPE	DRW
DISC	WD
NUMBER	6207
REV	AB