


NOTES:
 1. REFER TO W3-6001 FOR DRAWING INDEX, SETOUT DETAILS, GENERAL NOTES AND LEGEND.
 2. REFER TO W3-6002 FOR SET OUT TABLES.



File: P:\063\06310203 PROJECT INPUTS\11 LAD\DOWNER\CAM\608 FROM SHONTE\TOWN\KIN\2014\T\0\PROJECT\WSE\FILES\200\DRAWINGS\CAN\DRW\248222\0000\DRW\248222-0000-DRW-WD-6201-AB.DWG
 Plot Date: 24/03/2018 4:03:59 PM
 Other:

JOIN LINE REFER SHEET 2
 248222-0000-DRW-WD-6202

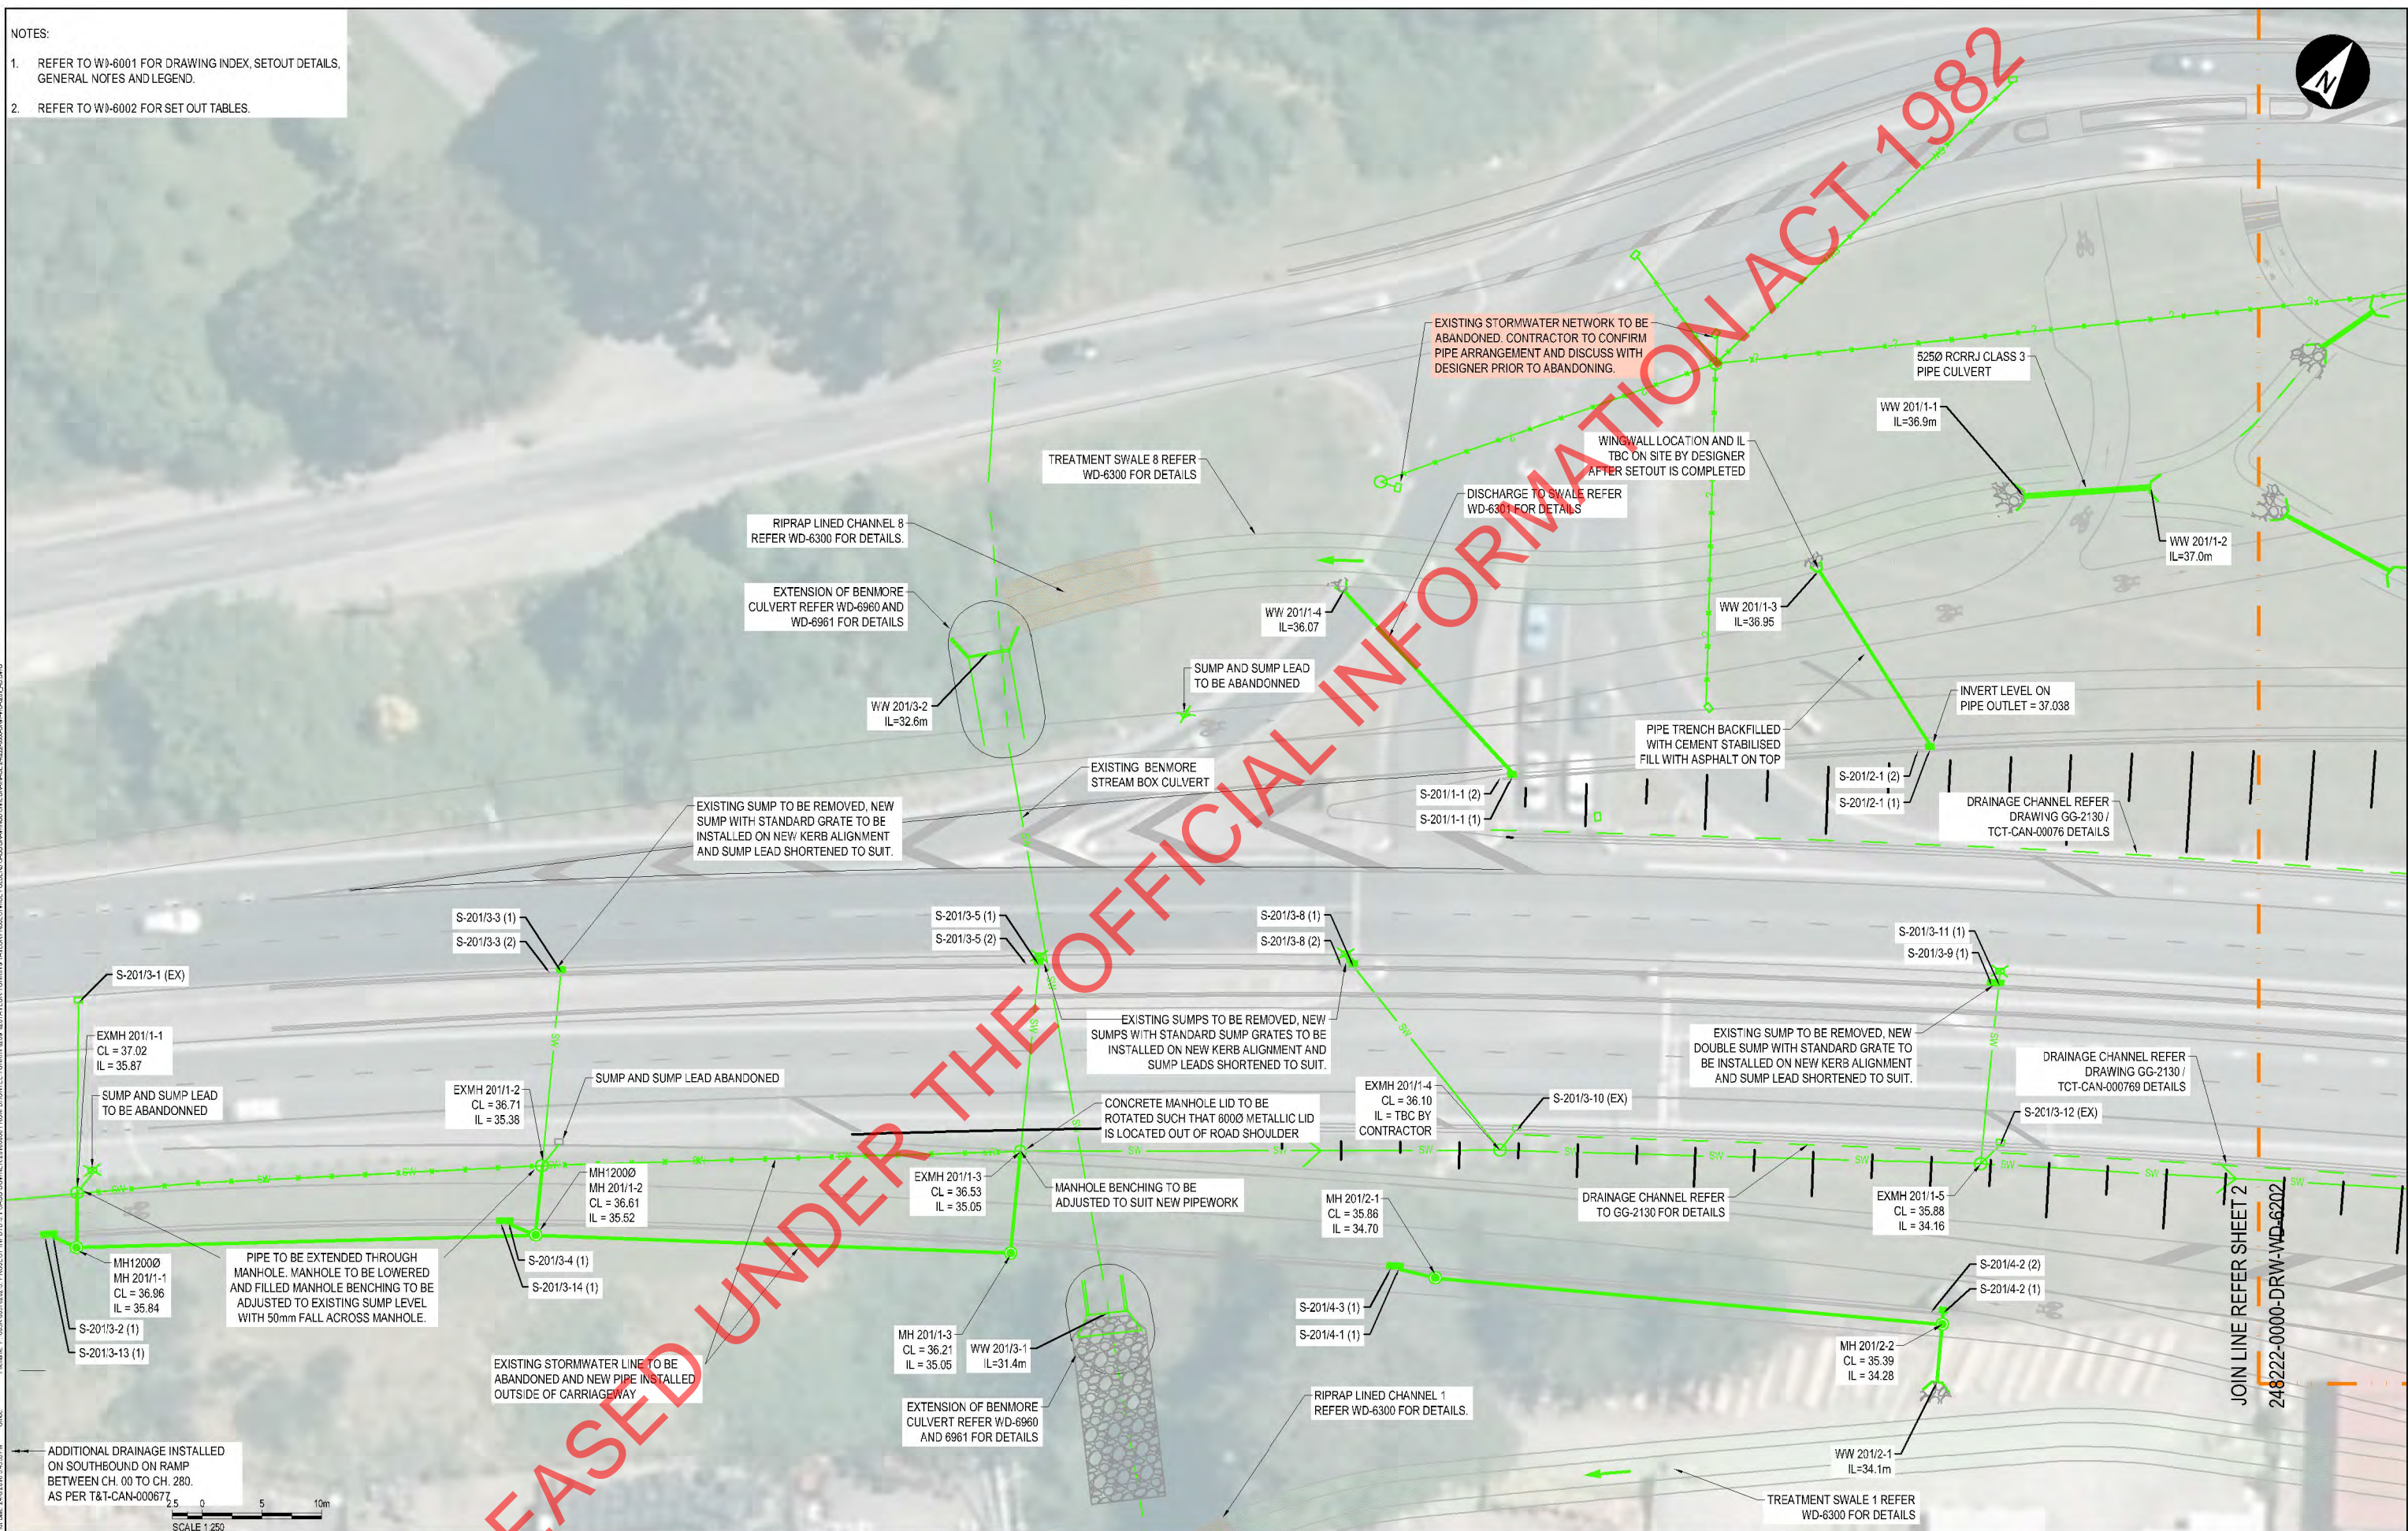

| REV | DATE | REVISION DETAILS | APPROVED |
|-----|----------|------------------|----------|
| AB | 22.06.18 | AS BUILT | |

| | |
|----------|----------|
| SCALE | 1:250 |
| SIZE | A1 |
| DRAWN | s9(2)(a) |
| DESIGNED | s9(2)(a) |
| CHECKED | s9(2)(a) |

| | | |
|----------|----------|------|
| AS BUILT | APPROVED | DATE |
|----------|----------|------|

| | | | | | | | | | | | | | |
|-------------|--|-------------|--------|-----|------|------|-----|------|----|--------|------|-----|----|
| PROJECT | SH2 - SH58 HAYWARDS INTERCHANGE | | | | | | | | | | | | |
| TITLE | STORMWATER DRAINAGE LAYOUT PLAN SHEET 1 OF 8 | | | | | | | | | | | | |
| DRAWING No. | 248222 | PROJECT No. | 248222 | WBS | 0000 | TYPE | DRW | DISC | WD | NUMBER | 6201 | REV | AB |